
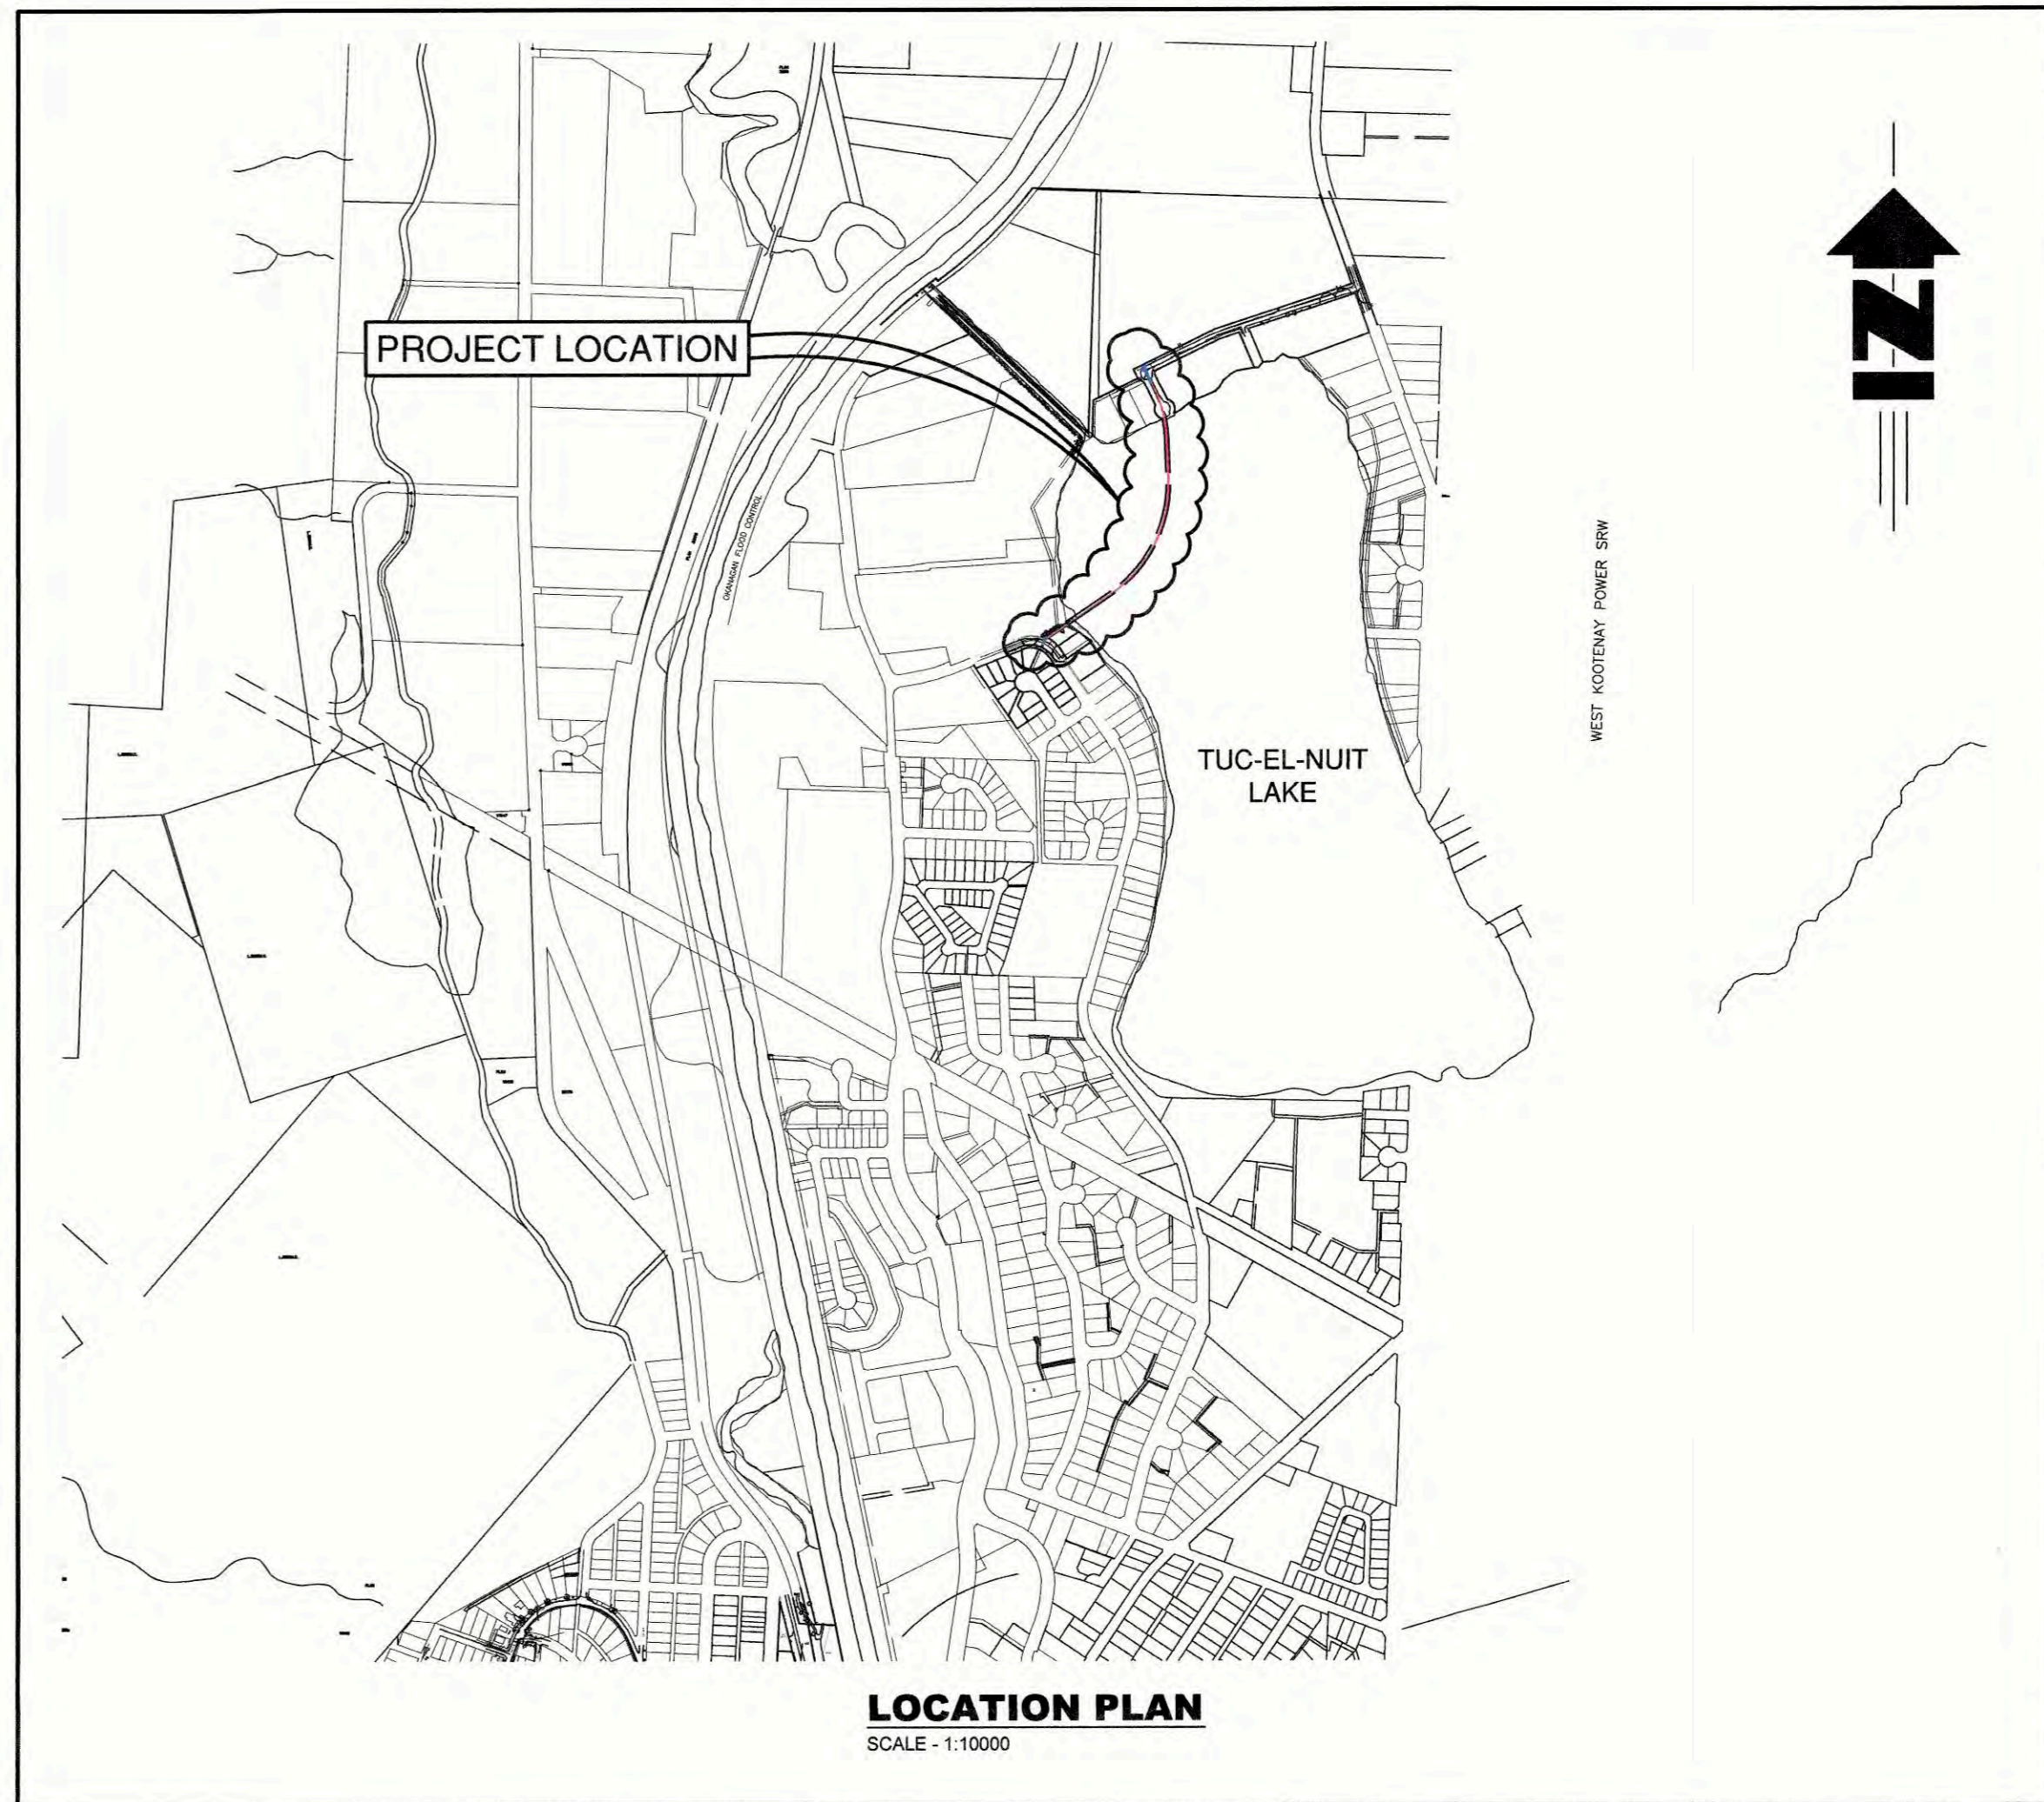


DRAWING LIST	
DRAWING NO.	TITLE
306-1731-01	LOCATION PLAN, SITE PLAN AND DRAWING LIST
306-1731-02	PLAN & PROFILE STA 0+000 TO STA 0+380
306-1731-03	PLAN & PROFILE STA 0+380 TO STA 0+520 AND DETAILS

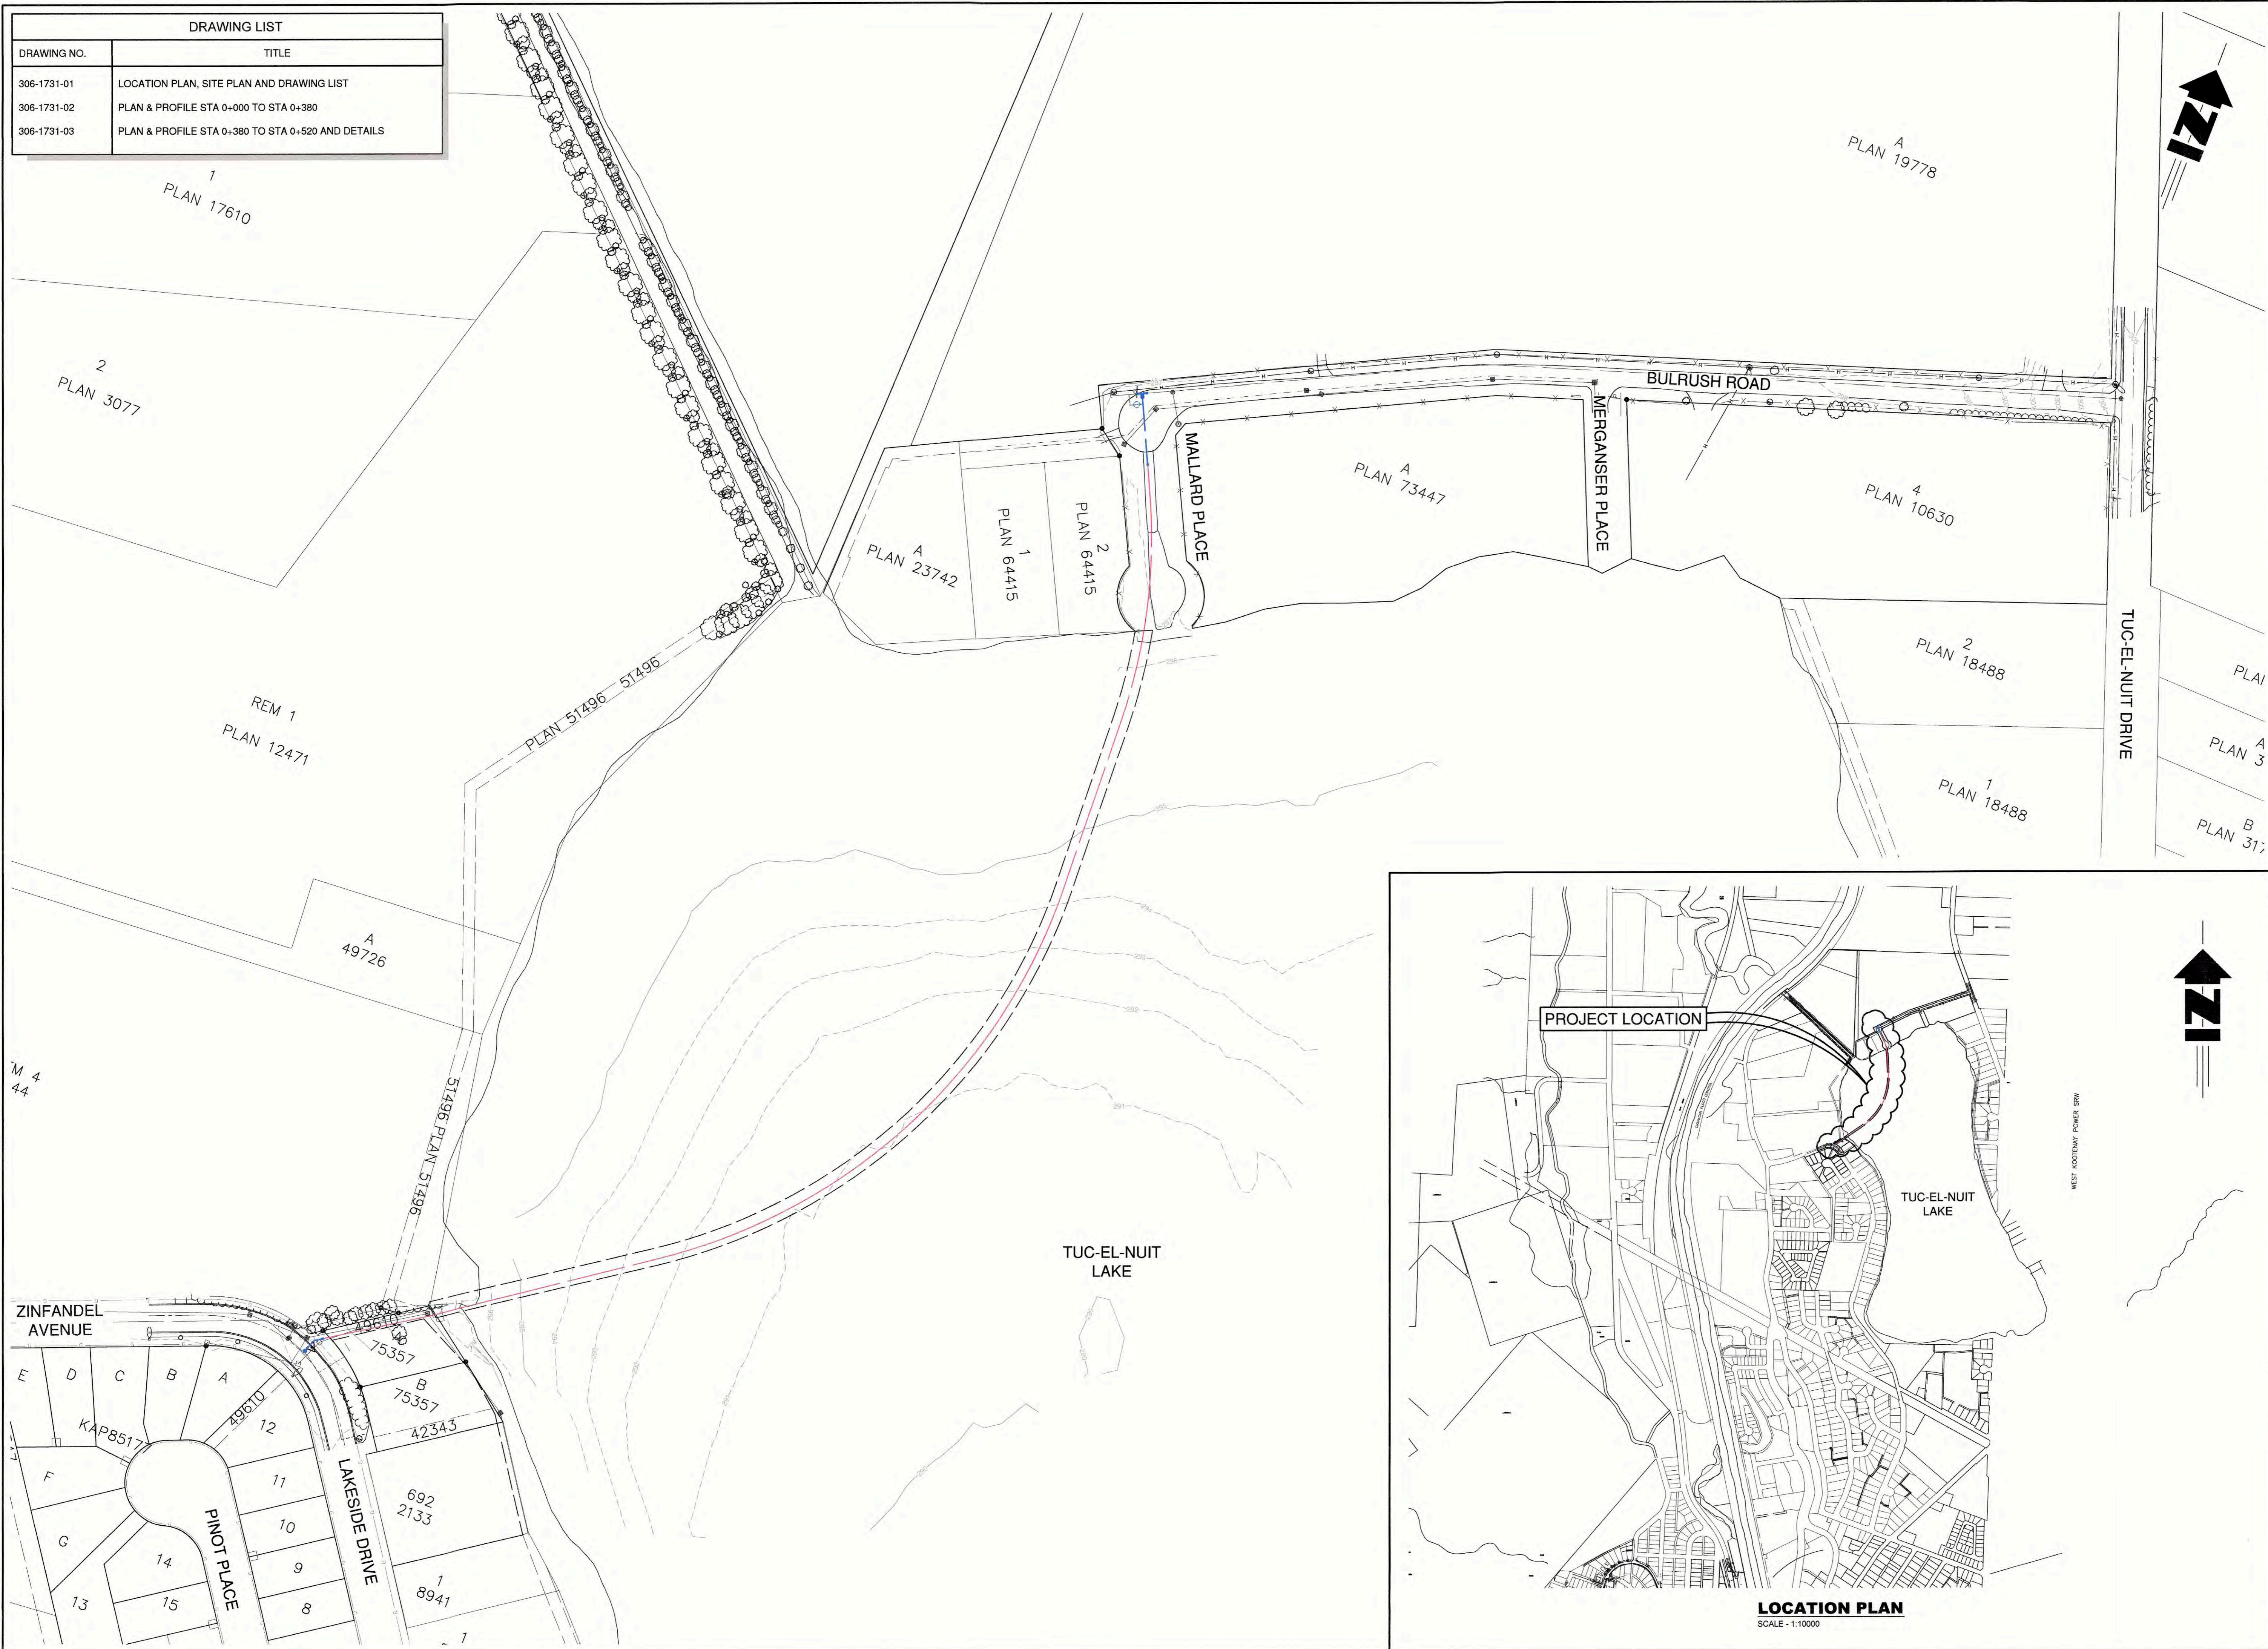


LEGEND		
EXISTING	PROPOSED	DESCRIPTION
		SANITARY MAIN
		SANITARY FORCE MAIN
		SANITARY MANHOLE
		CLEANOUT
		LIFT STATION
		SEPTIC TANK
		STORM MAIN
		STORM DITCH
		CULVERT
		STORM MANHOLE
		CATCHBASIN
		STORM DRYWELL
		WATER MAIN
		WATER SERVICE
		CURB STOP
		VALVE
		STANDPIPE
		HYDRANT
		AIR RELEASE VALVE
		REDUCER
		SPRINKLER
		IRRIGATION BOX
		END CAP
		POWER
		TEL
		CABLE
		STREET LIGHT
		GAS
		POWER POLE
		LAMP STANDARD
		LIGHT POST
		POLE ANCHOR
		JUNCTION BOX
		TEST PIT
		IRON PIN
		SURVEY CONTROL

No.	DATE	DESCRIPTION	BY	APP'D
3	NOV 2017	ISSUED FOR TENDER	SAC	SAC
2	JULY 12/17	REVISED PER I/A COMMENTS	SAC	SAC
1	JUN 15/17	ISSUED FOR REVIEW	SPC	SAC

ISSUES / REVISIONS	



TRUE CONSULTING
 201 - 2079 Falcon Road • Kamloops BC • V2C 4J2
 tel 250.828.0881 • fax 250.828.0717
 info@TRUE.bc.ca

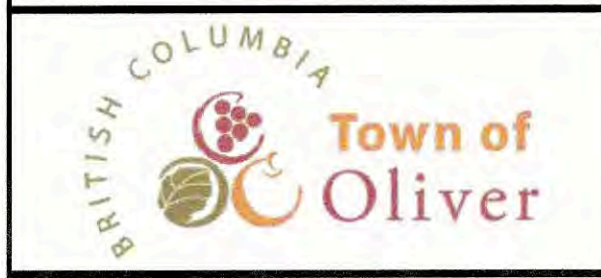

WATERMAIN LOOPING AT HEAD OF LAKE

LOCATION PLAN, SITE PLAN AND DRAWING LIST

SCALE 0 1:1000 50
DESIGN BY SAC / SU
DRAWN BY KD / SPC
DATE JUNE 2017
PROJECT REFERENCE No. 306-1731
DRAWING No. 306-1731-01
SHEET 1 OF 3
ISSUE/REV. 3